



SLICES @ CROSSROADS and 4th

DESIGNS BY:




DESIGNER: jaf
DRAWN: jaf
MODEL: jaf

DATE: 11/30/08
REVES: 01/04/09

CROSSROADS AT
4th & CENTRAL LLC.
ALBUQUERQUE, NM 87102

Designs, Concepts, Floor Plans & Blueprints are
Copyrighted 2008 and are the property of
James Andrew Fenton, Jr. and/or JAF Concepts.



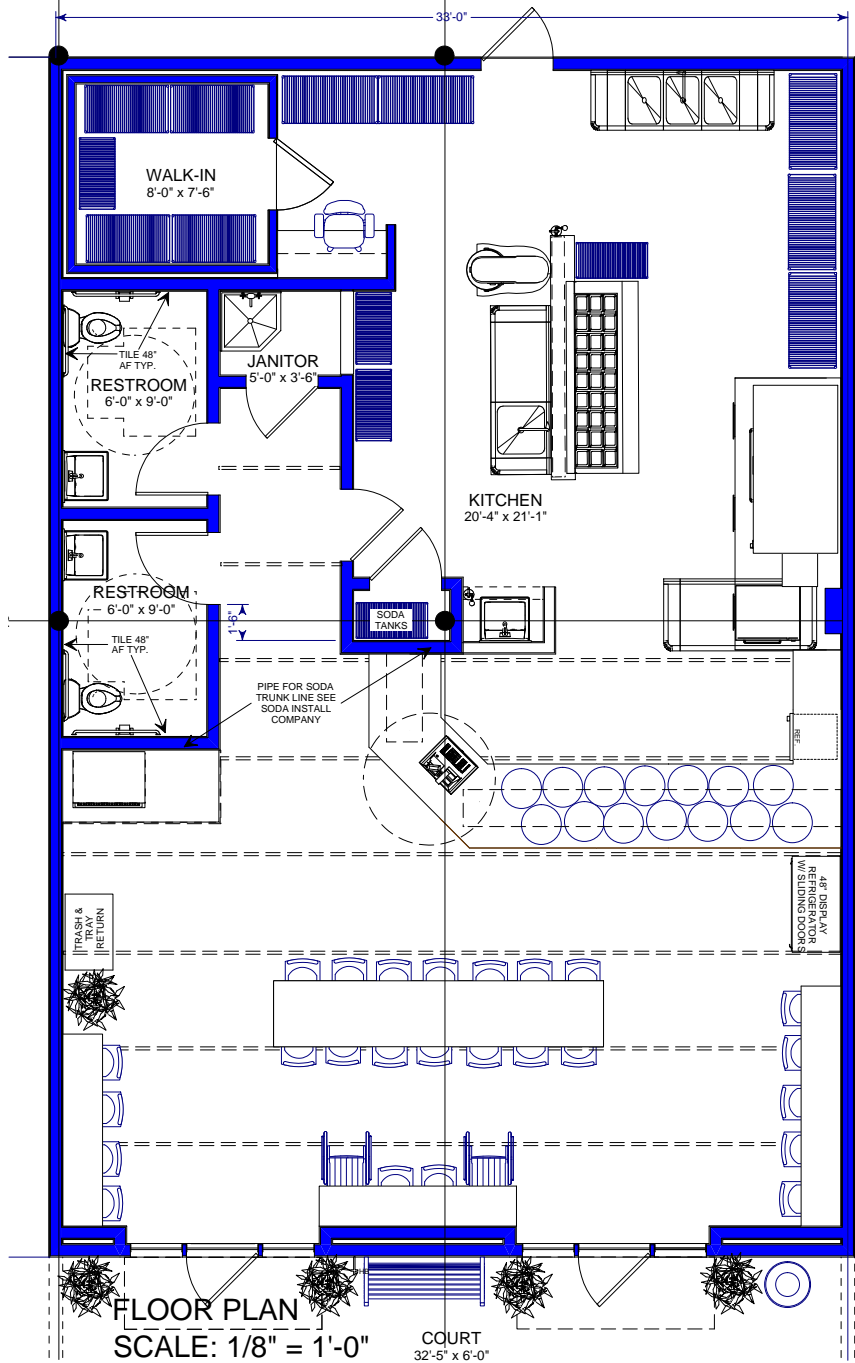

SLICES AT

4th & CENTRAL LLC.
4th & CENTRAL LLC.
ALBUQUERQUE, NM 87102

Designs, Concepts, Floor Plans & Blueprints are
Copyrighted 2008 and are the property of
James Andrew Fenton, Jr. and/or JAF Concepts.

DESIGNS BY:



DESIGNER: jaf
DRAWN: jaf
MODEL: jaf

DATE: 11/30/08
REVES: 01/04/09





DESIGNS BY:



DESIGNER: jaf
 DRAWN: jaf
 MODEL: jaf

DATE: 11/30/08
 REVES: 01/04/09

SLICES AT

4th & CENTRAL LLC.
 4th & CENTRAL LLC.
 ALBUQUERQUE, NM 87102

Designs, Concepts, Floor Plans & Blueprints are
 Copyrighted 2008 and are the property of
 James Andrew Fenton, Jr. and/or JAF Concepts.





SLICES AT

**4th & CENTRAL LLC.
4th & CENTRAL LLC.
ALBUQUERQUE, NM 87102**

Designs, Concepts, Floor Plans & Blueprints are
Copyrighted 2008 and are the property of
James Andrew Fenton, Jr. and/or JAF Concepts.


DESIGNS BY:



DESIGNER: jaf
DRAWN: jaf
MODEL: jaf

DATE: 11/30/08
REVES: 01/04/09



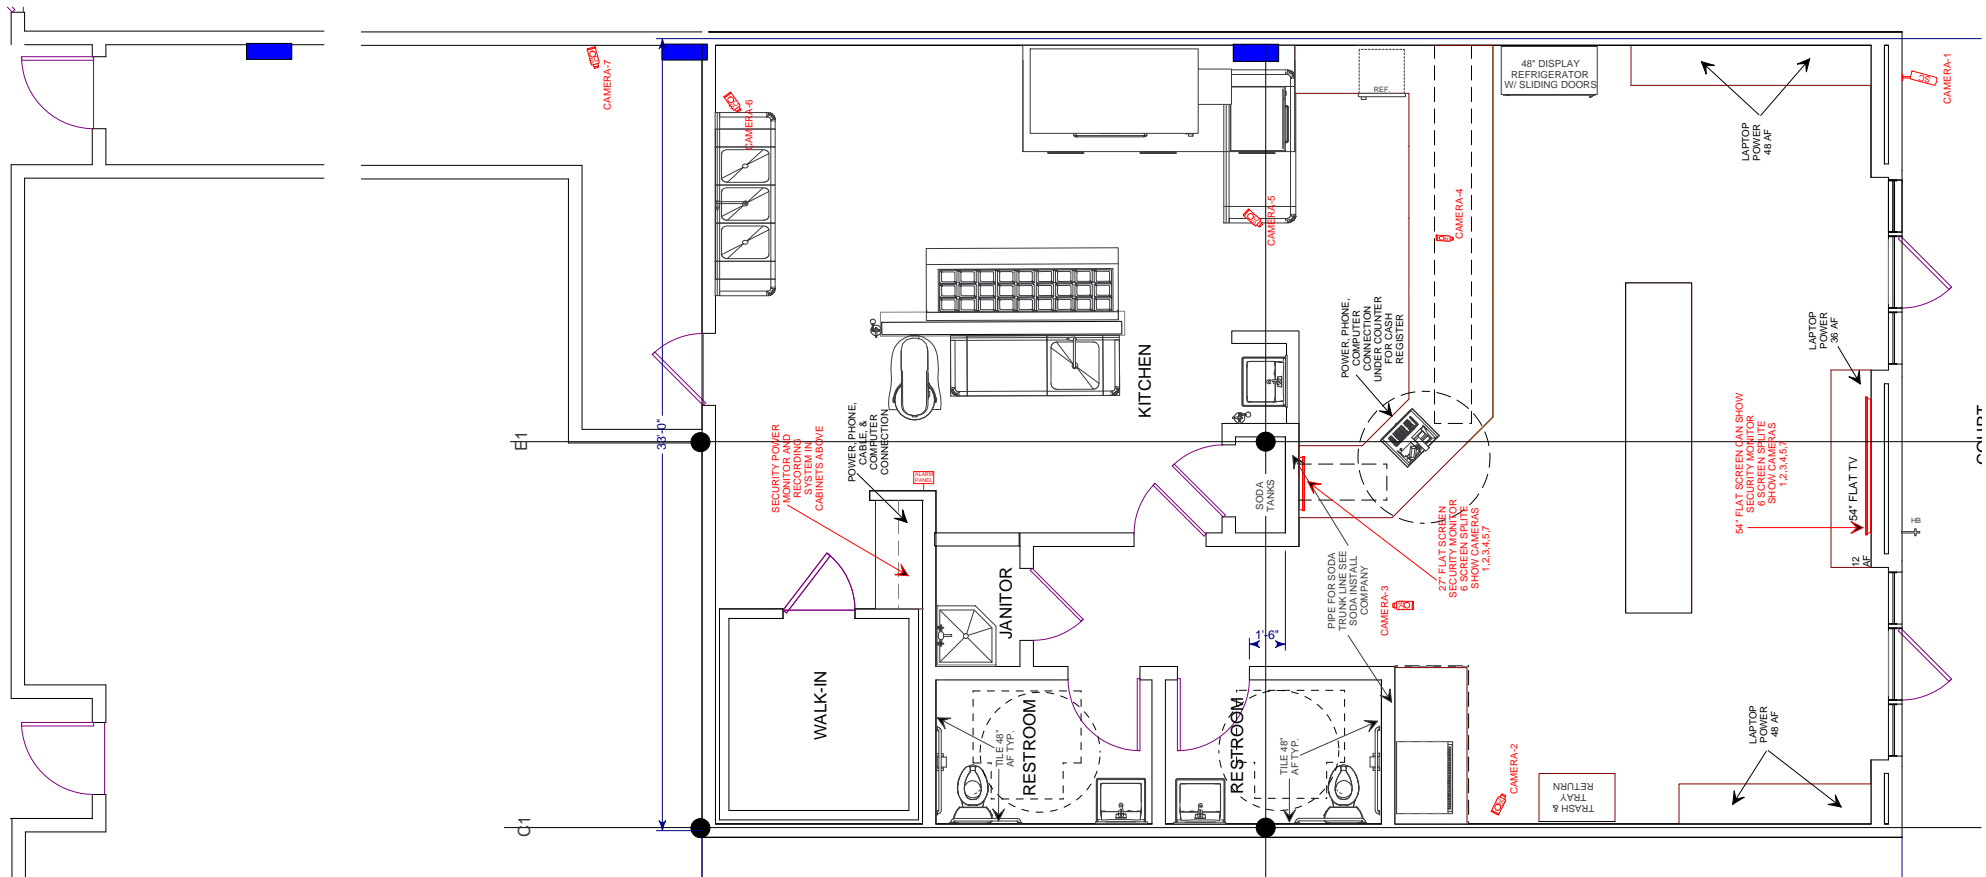

SECURITY PLAN
SCALE: 1/8" = 1'-0"

DESIGNS BY:



DESIGNER: jaf
 DRAWN: jaf
 MODEL: jaf

DATE: 11/30/08
 REVS: 01/04/09

CROSSROADS AT
4th & CENTRAL LLC.
ALBUQUERQUE, NM 87102

Designs, Concepts, Floor Plans & Blueprints are
 Copyrighted 2008 and are the property of
 James Andrew Fenton, Jr. and/or JAF Concepts.

